




STUCKEY ARCHITECTS
 ARCHITECTURE PLANNING INTERIORS
 208 N. MAIN STREET, SUITE 140
 WEATHERFORD, TEXAS 76086
 TELEPHONE (817) 341-0754
 FAX (817) 341-0755
 EMAIL: rastuckey@stuckeyarchitects.com



FEBRUARY 9, 2018
 ROBERT A. STUCKEY
 ARCHITECT, TEXAS #3093

D1 FITNESS CENTER
 THE GROVES OF ALEDO

ALEDO, TEXAS

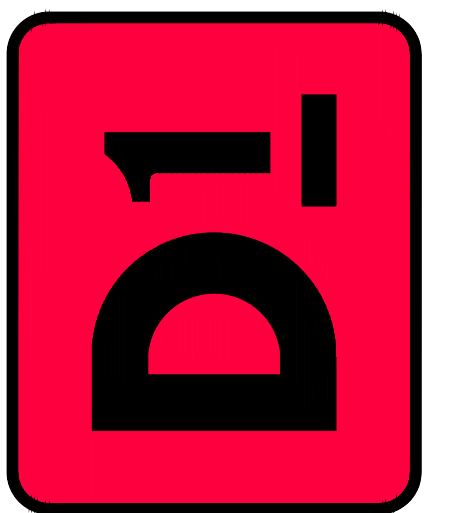

REFLECTED CEILING PLAN


REVISIONS

DRAWN BY: RAS PROJ. MGR.: RAS
 DATE: FEBRUARY 9, 2018 PROJ. NO:


SHEET NO.

A5.1

SHEET
 20 OF 35

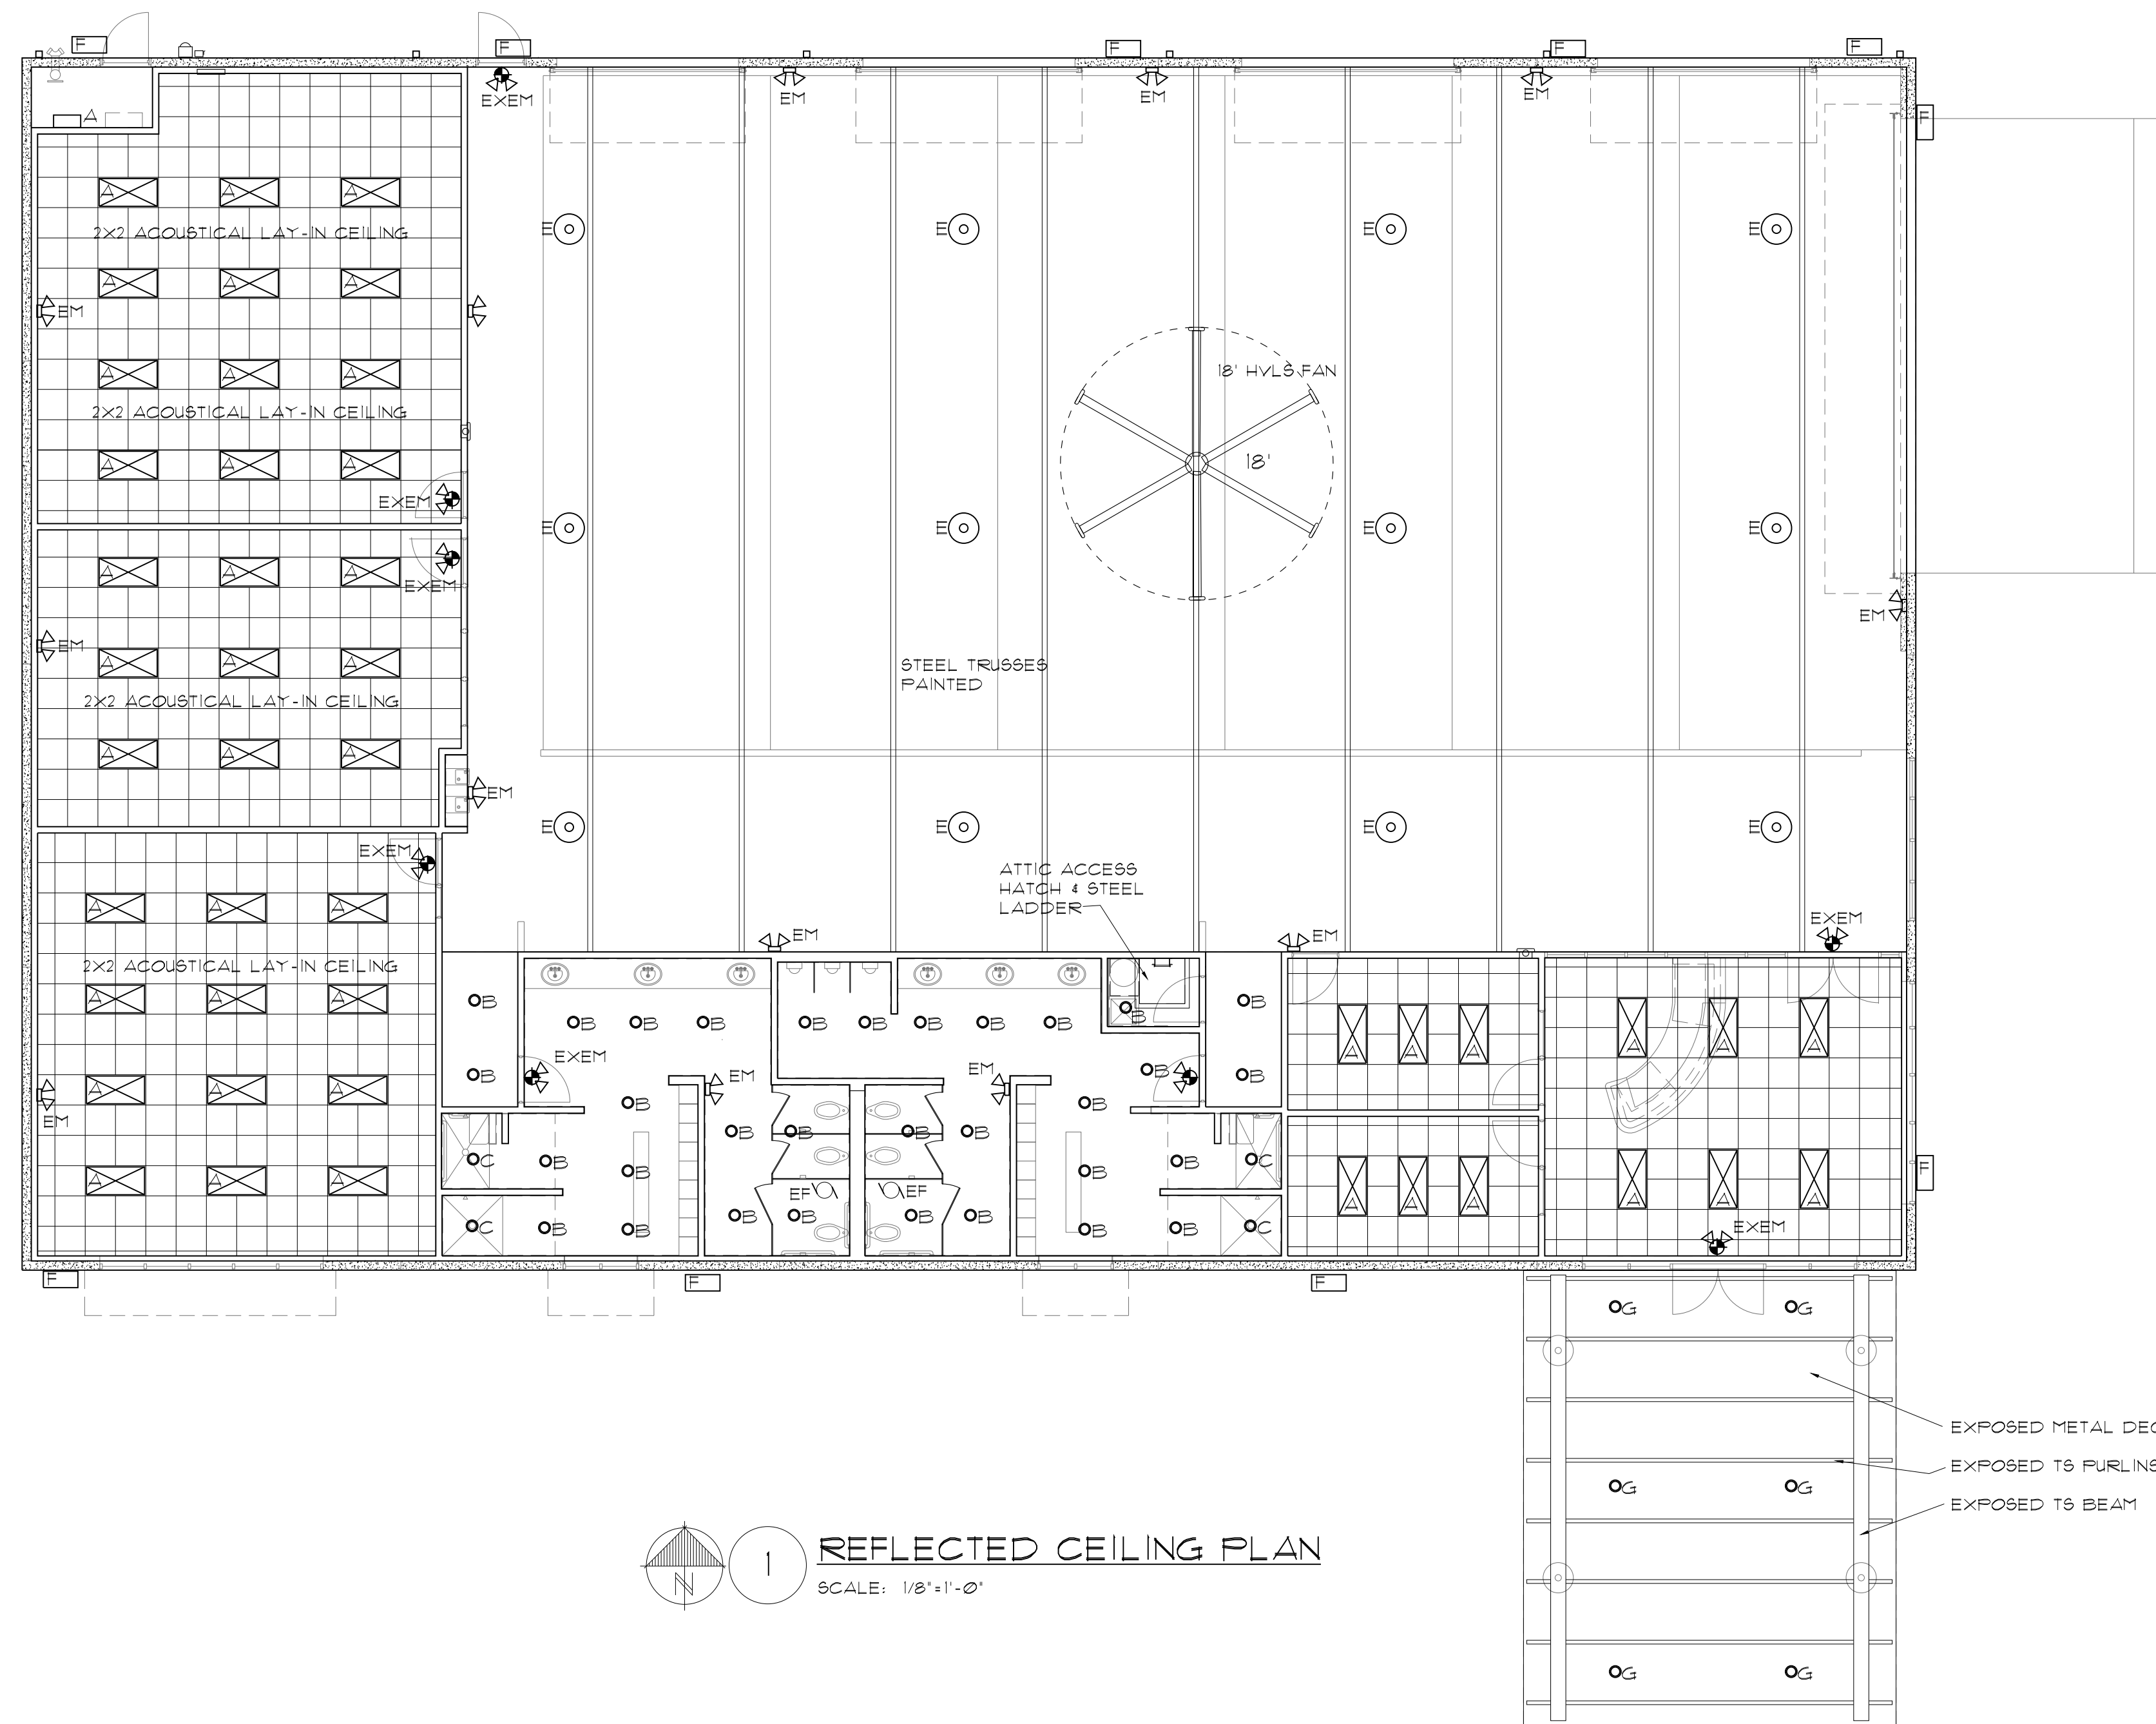

1 REFLECTED CEILING PLAN
 SCALE: 1/8"=1'-0"

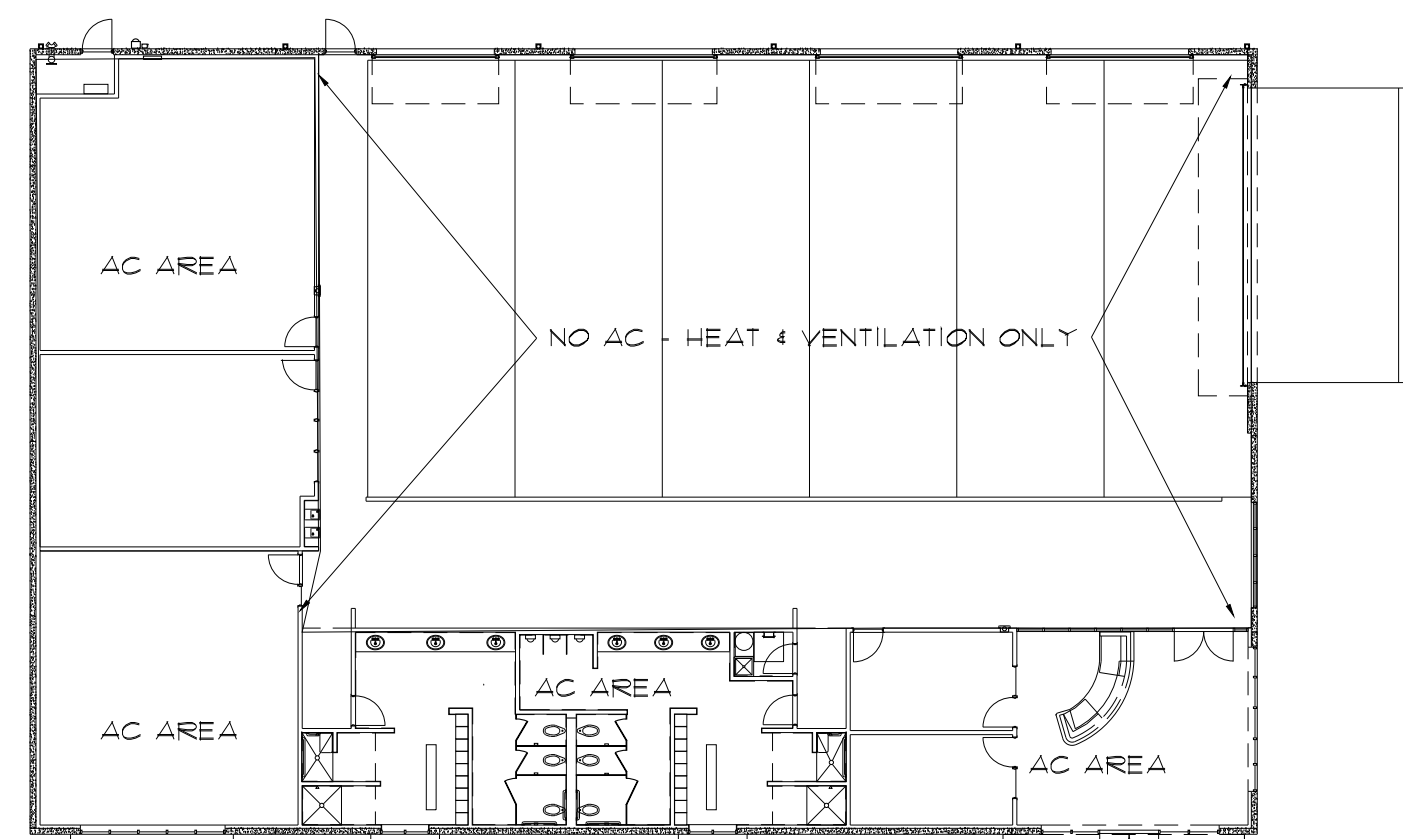

2 1ST FLOOR HVAC AREAS
 SCALE: NTS

FIXTURE SCHEDULE		
A	2X4 ACOUSTICAL LAY-IN	LED LAMPS
B	RECESSED DOWNLIGHT	LED LAMP
C	RECESSED DOWNLIGHT W/ LENS	LED LAMP
D	SURFACE MOUNT WRAP LENS	LED LAMPS
E	HIGH BAY LIGHT FIXTURE	LED LAMPS
F	EXTERIOR WALL PACK	LED LAMPS
G	EXTERIOR DOWNLIGHTS	LED LAMP
H	WALL MOUNTED LED	LED LAMPS
	EXIT LIGHT W/ EMERGENCY LIGHTS	LED LAMPS
	EMERGENCY LIGHTS	LED LAMPS
	EXHAUST FAN	
	2X4 LAY-IN CEILING W/ 6" BATT INSULATION	
	DRYWALL CEILING - TBTP W/ SUSPENSION SYSTEM	