




STUCKEY ARCHITECTS
 ARCHITECTURE PLANNING INTERIORS
 208 N. MAIN STREET, SUITE 140
 WEATHERFORD, TEXAS 76086
 TELEPHONE: (817) 341-0754
 FAX: (817) 341-0755
 EMAIL: ras@stuckeyarchitects.com



FEBRUARY 9, 2018
 ROBERT A. STUCKEY
 ARCHITECT, TEXAS #3093

D1 FITNESS CENTER
 THE GROVES OF ALEDO

ALEDO, TEXAS

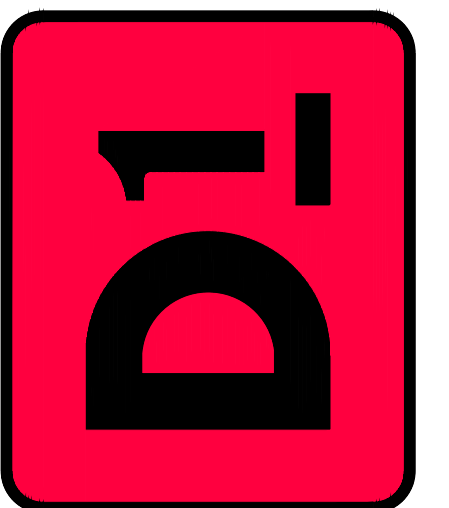

FIRE PROTECTION


REVISIONS

DRAWN BY: RAS PROJ. MGR.: RAS
 DATE: FEBRUARY 9, 2018 PROJ. NO.:


SHEET NO.

FP1.1

SHEET
 22 OF 35

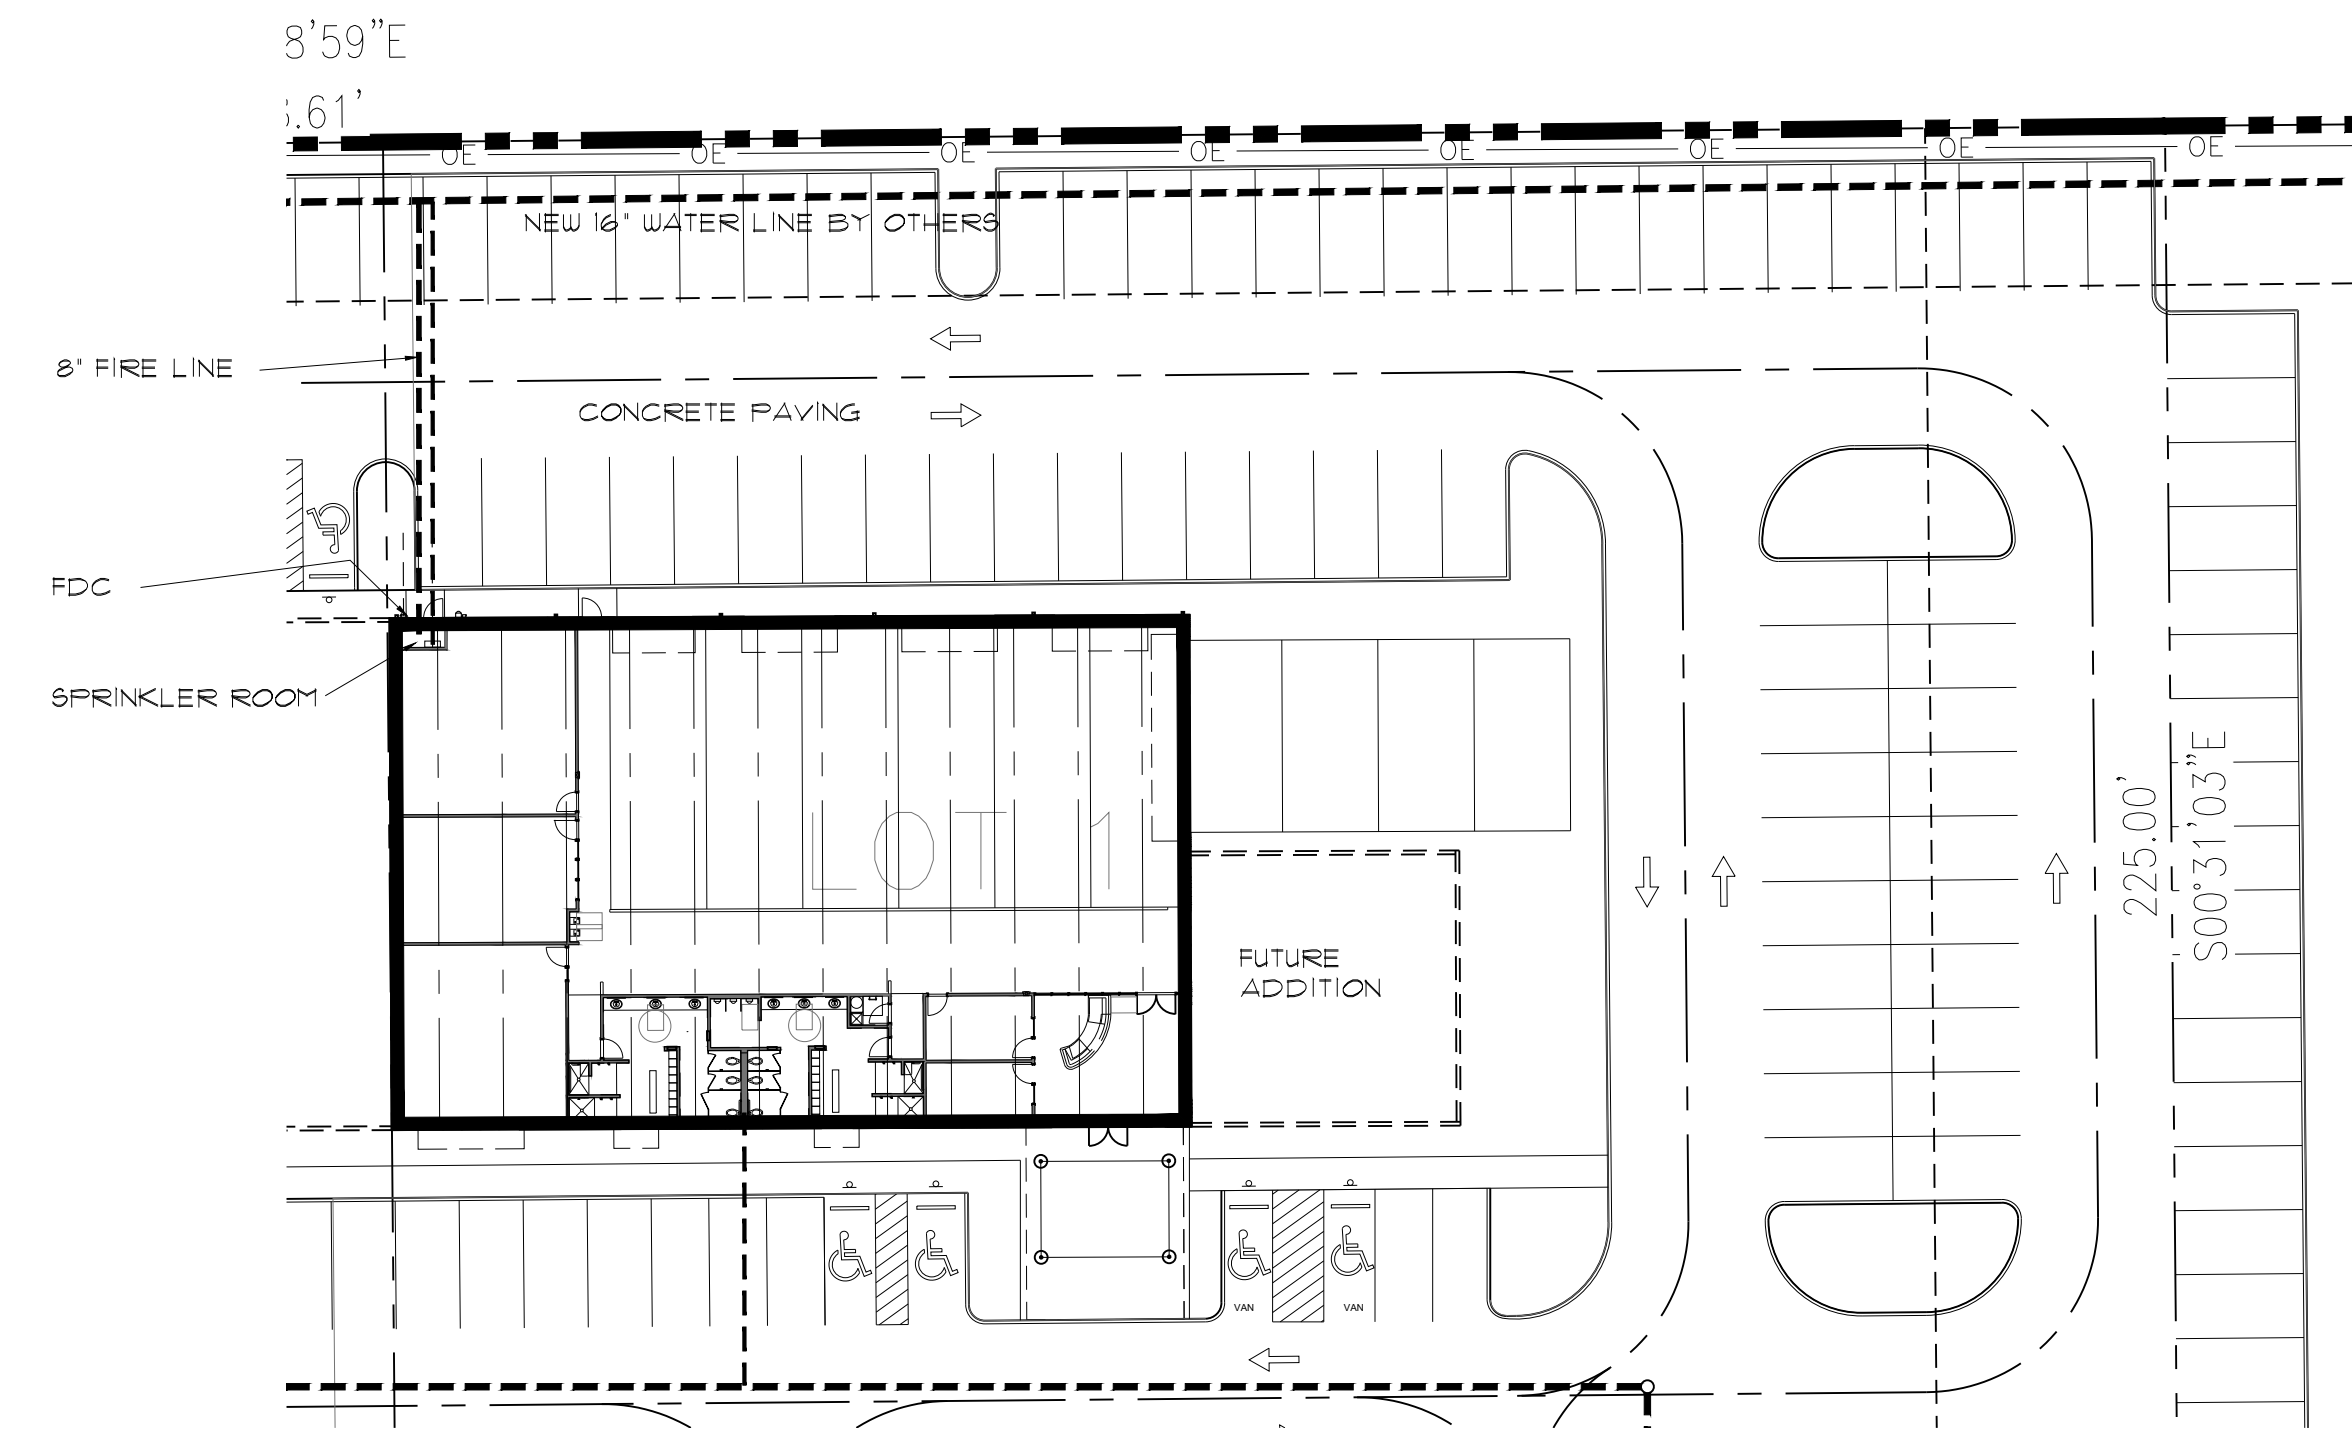

1 SITE PLAN - FIRE PROTECTION
 SCALE: 1" = 30'-0"

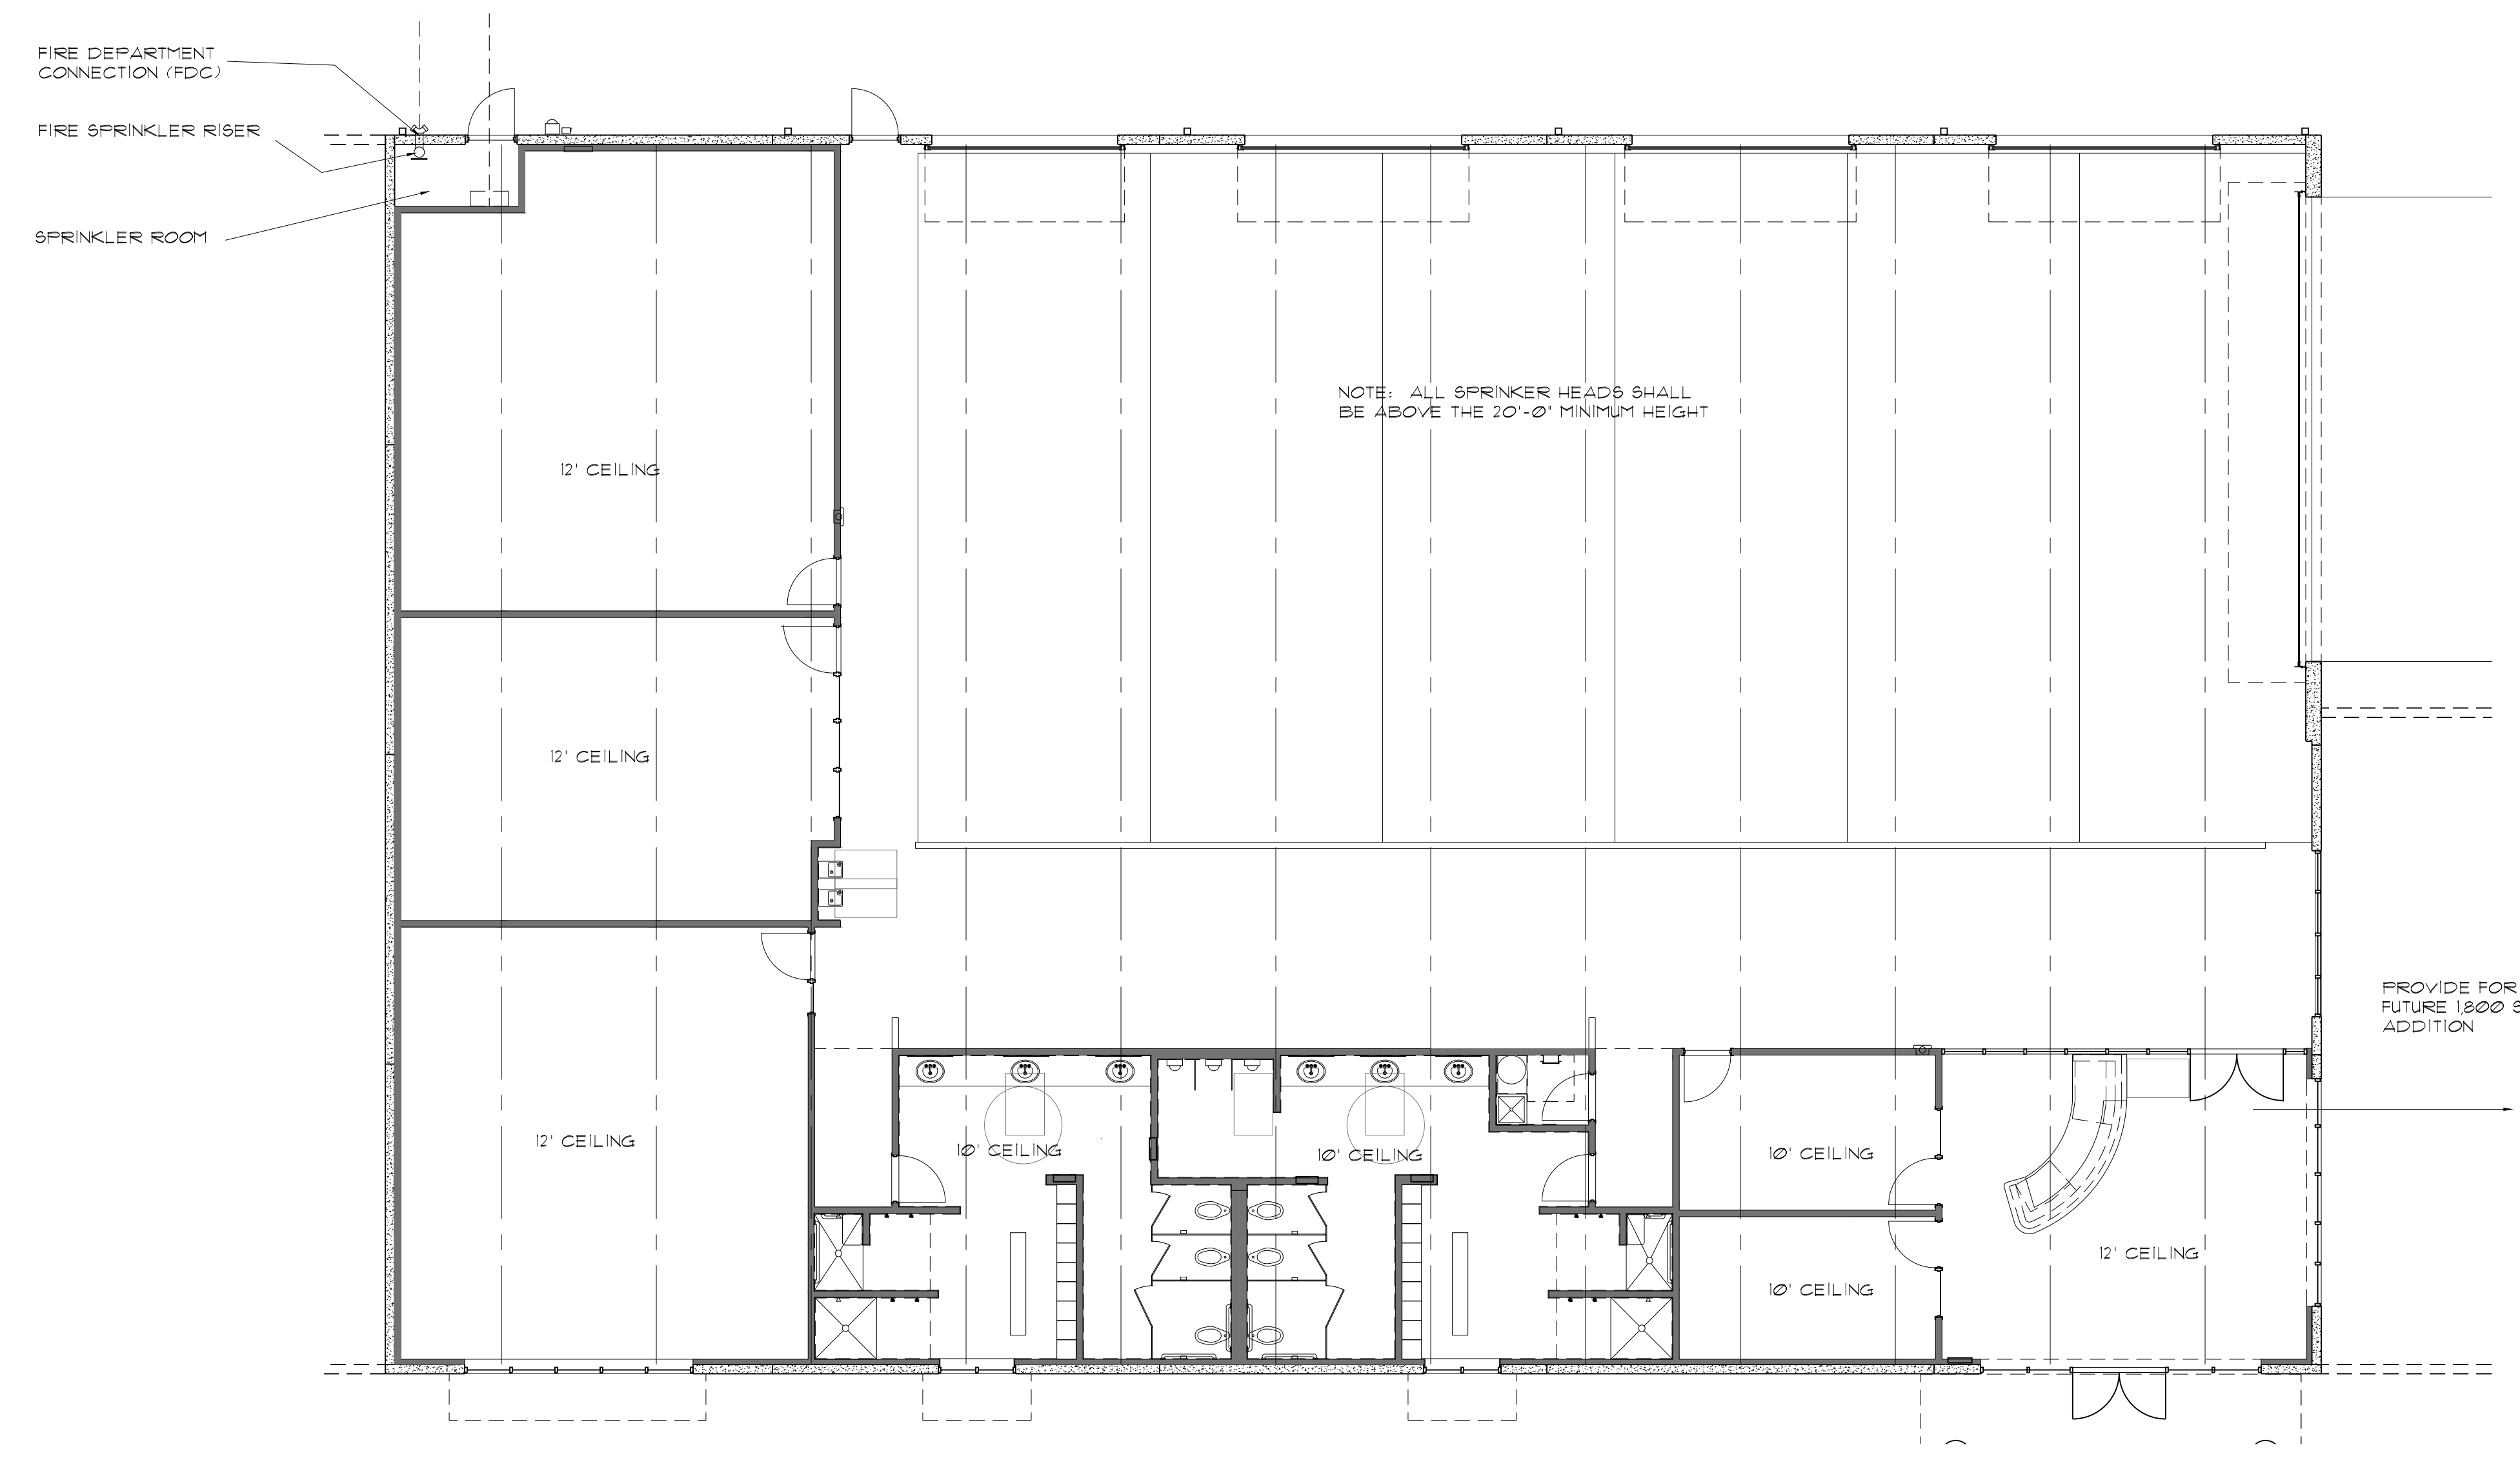

AREA = 10,000 SF
2 FLOOR PLAN - FIRE PROTECTION
 SCALE: 1/16" = 1'-0"

THIS BUILDING SHALL HAVE AN APPROVED FIRE SPRINKLER SYSTEM
 & AN APPROVED FIRE ALARM SYSTEM
 MEET OR EXCEED NFPA 13